


PRODUCT NUMBER	TYPE	TOP CAGE HOLE	PACKAGE
10122382-302LF	2 EMI SUPPRESSION PINS IN TOP CAGE & COMPLIANT PINS IN BOTTOM CAGE	WITH HOLE	TRAY
10122382-402LF	2 EMI SUPPRESSION PINS IN TOP CAGE & NO COMPLIANT PINS IN BOTTOM CAGE	WITH HOLE	TRAY

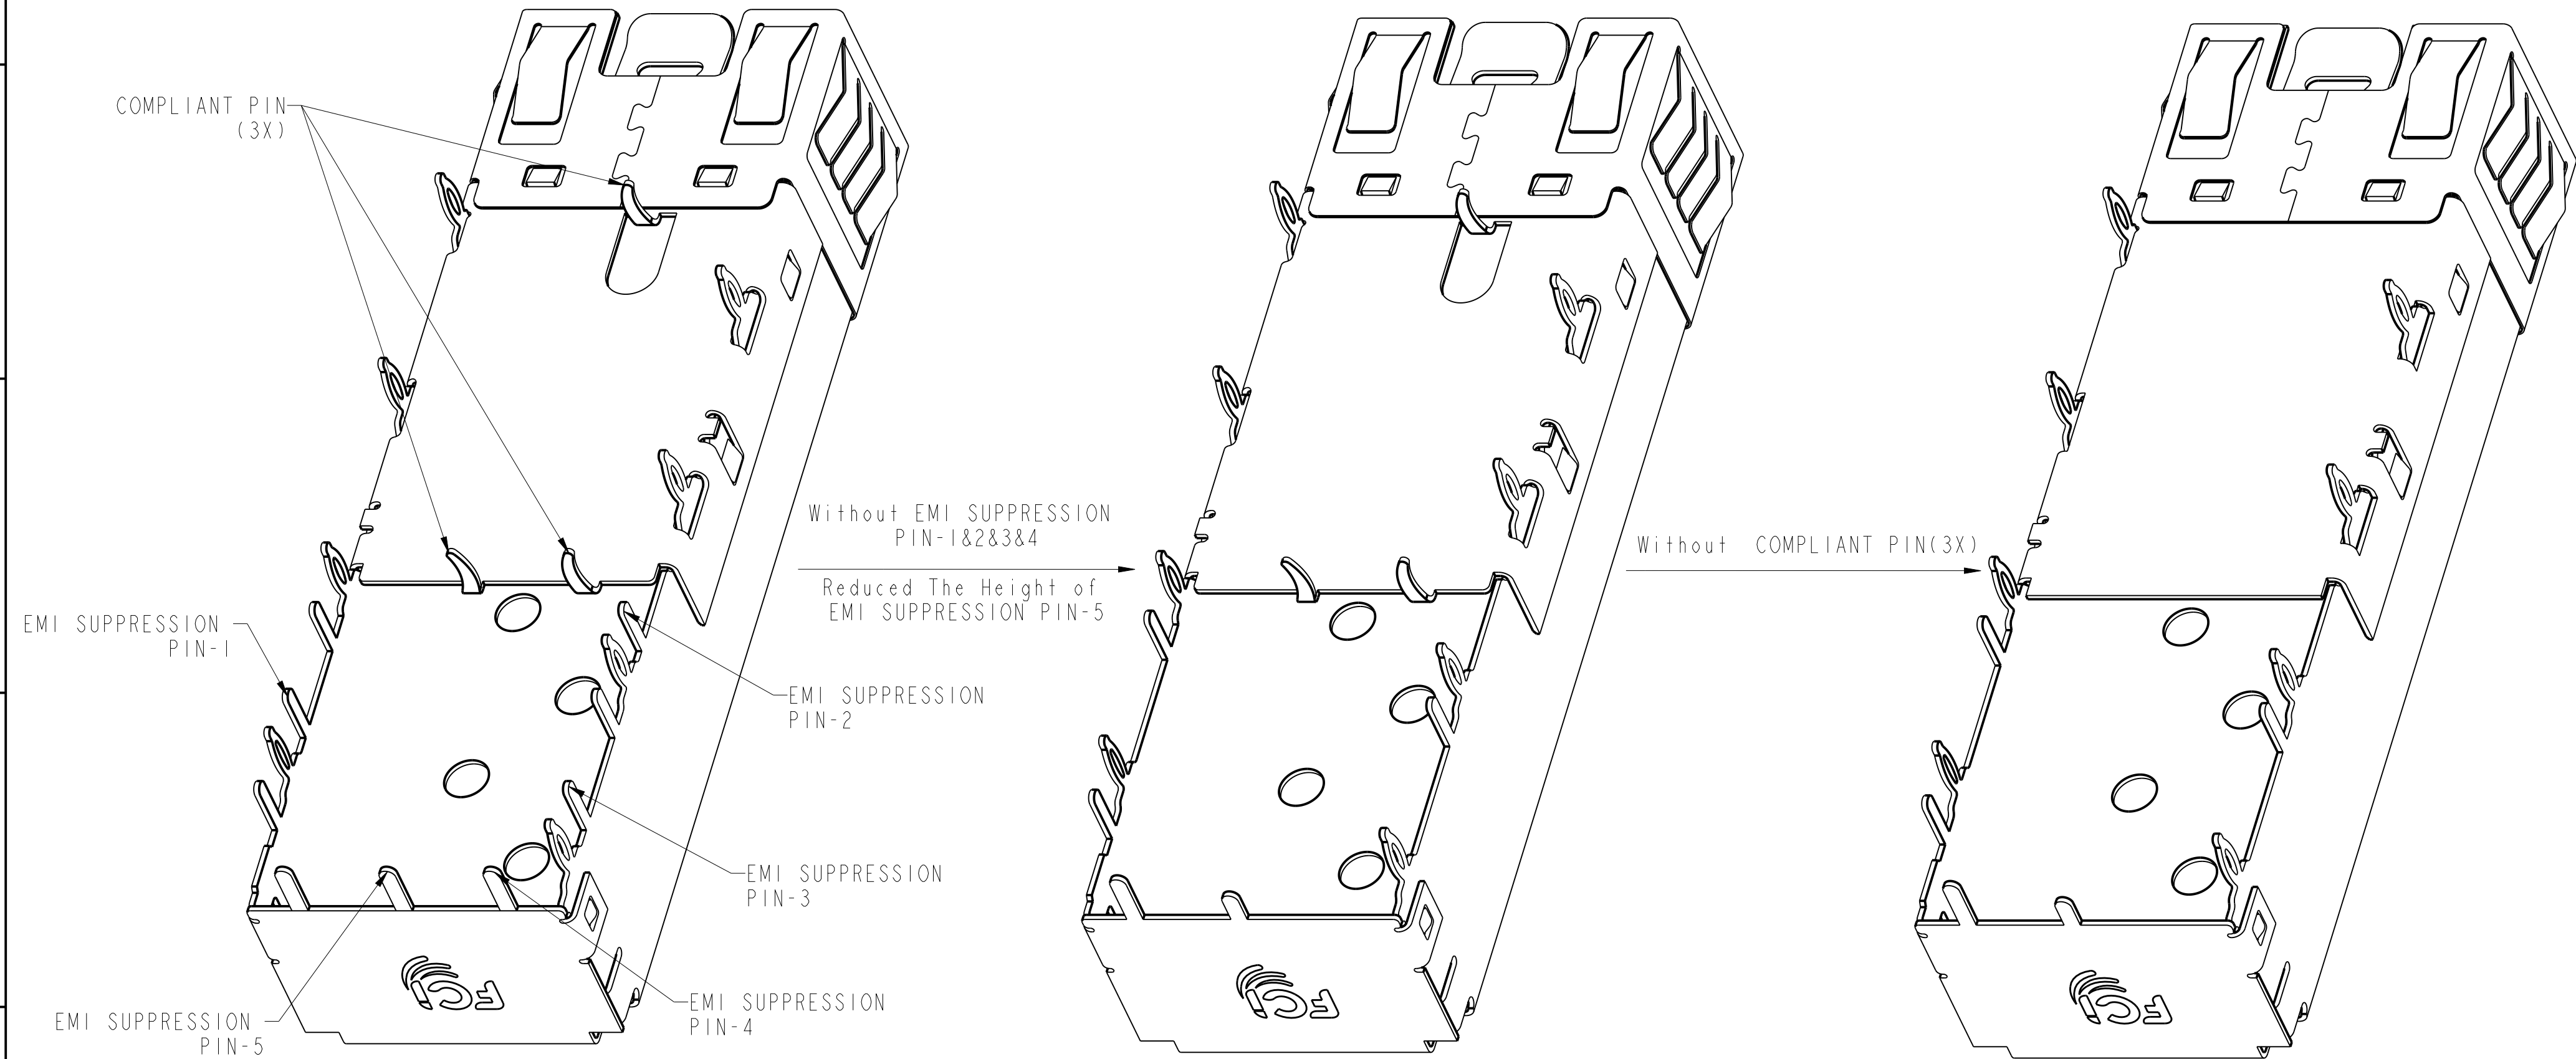

10122382-102LF

10122382-302LF

10122382-402LF


10122382-302LF/402LF WILL ALLOW FOR BELLY TO BELLY MOUNTING.

spec ref		RELEASE		dr		ART LIN		2014-03-20		projection		MM		size		scale	
tolerance std		TOLERANCES UNLESS OTHERWISE SPECIFIED		eng										A2		5:1	
ISO 406				chr		COLLINS LU		2014-03-21						ecn no			
ISO 1101				appr		JEFFREY QIN		2014-03-21		product family				rel level		Released	
surface			linear	0.X	±0.25			title		SFP+ IXI Cage		dwg no		10122382		rev	
				0.XX	±0.15												
				0.XXX	±												
ISO 1302		angular	0°	±2°	www.fci.com		cat. no.				Product - Customer Drw		sheet 2 of 6				


PDS: Rev :C

STATUS:Released


Printed: Apr 01, 2014

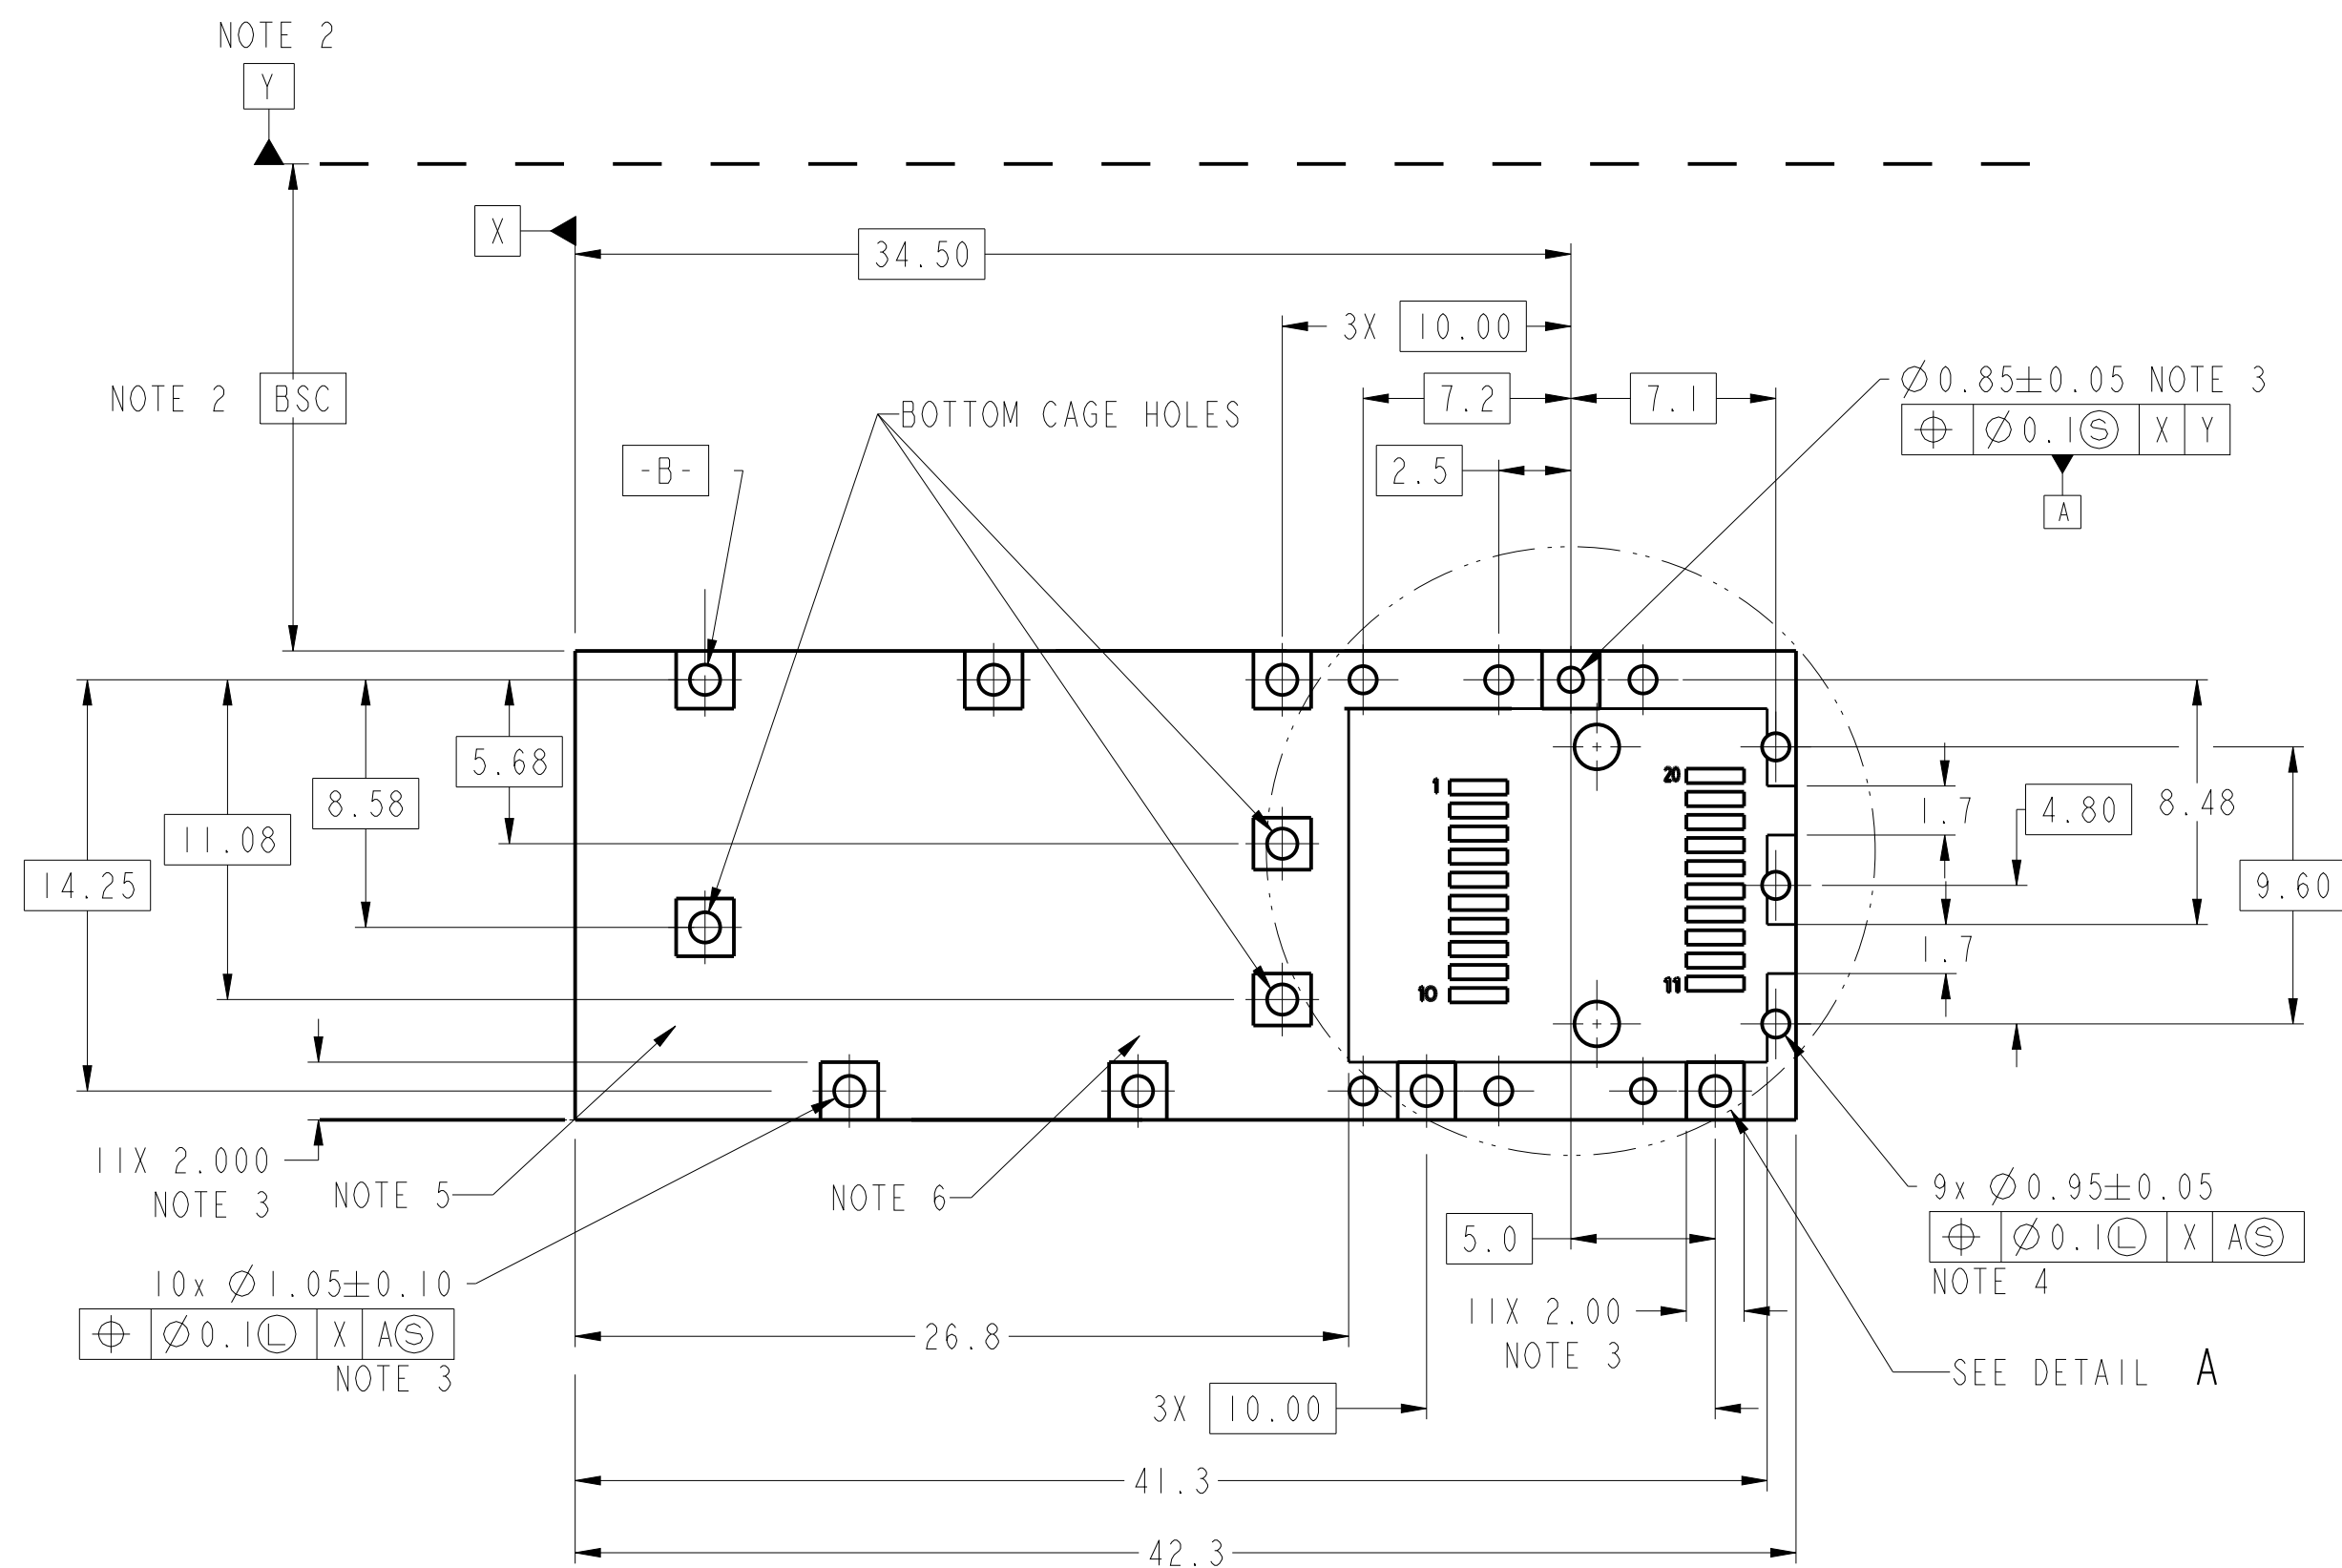

10122382-101LF/102LF/302LF/502LF
HOST BOARD MECHANICAL LAYOUT
SINGLE SIDED APPLICATIONS

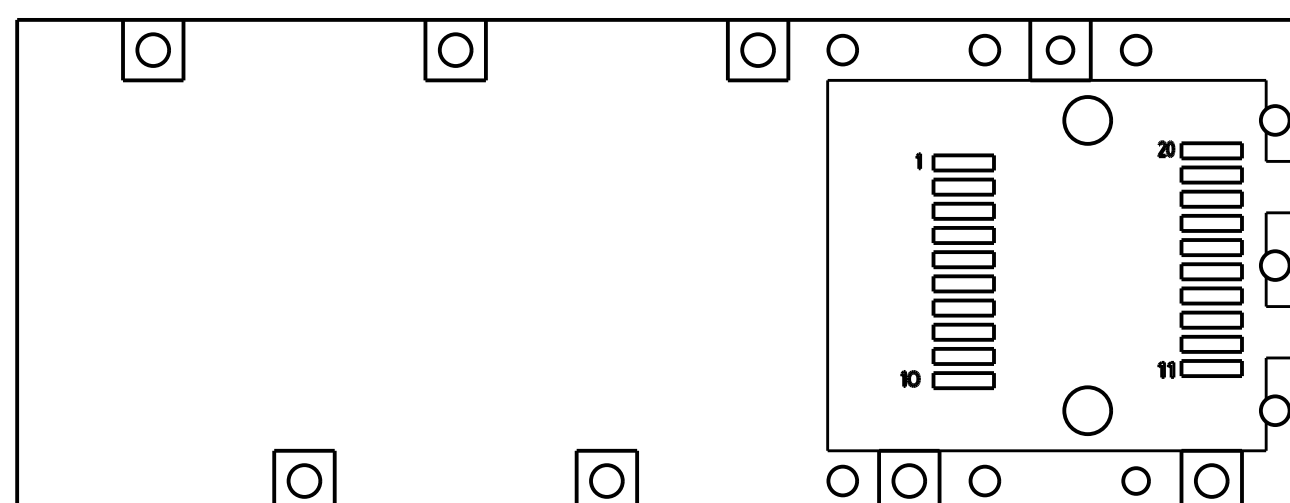

10122382-202LF
HOST BOARD MECHANICAL LAYOUT
SINGLE SIDED APPLICATIONS
(ONLY WITHOUT BOTTOM CAGE HOLES)

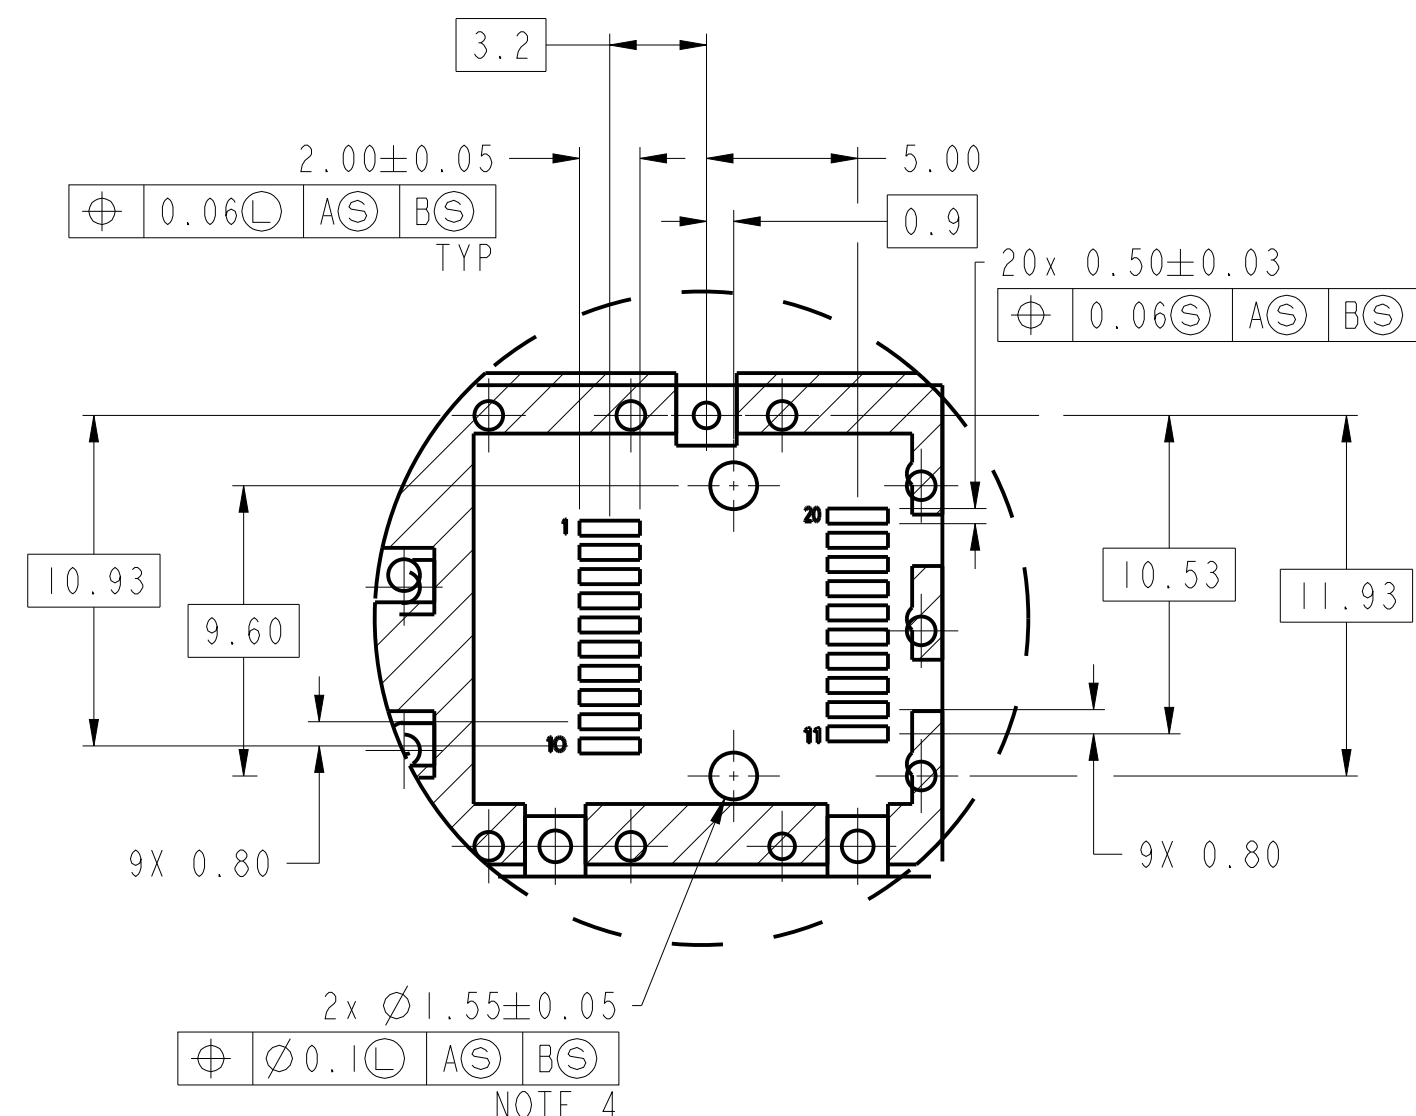

DETAIL A: HOST CONNECTOR LAYOUT
SCALE 4:1


NOTE:
SEE SHEET 4 FOR
HOST CONNECTOR LAYOUT

spec ref	RELEASE	dr	ART LIN	2014-03-20	projection	MM	size	A2	scale	4:1
tolerance std	TOLERANCES UNLESS OTHERWISE SPECIFIED	eng	COLLINS LU	2014-03-21	chr	JEFFREY QIN	ecn no			
ISO 406		app		2014-03-21	product family	SFP +	rel level	Released		
ISO 1101										
surface	linear	0.X	±0.25							
		0.XX	±0.15							
		0.XXX	±							
ISO 1302	angular	0°	±2°							
www.fci.com		cat. no.		Product - Customer Drw		sheet 4 of 6				

PDS: Rev :C


STATUS: Released

Printed: Apr 01, 2014

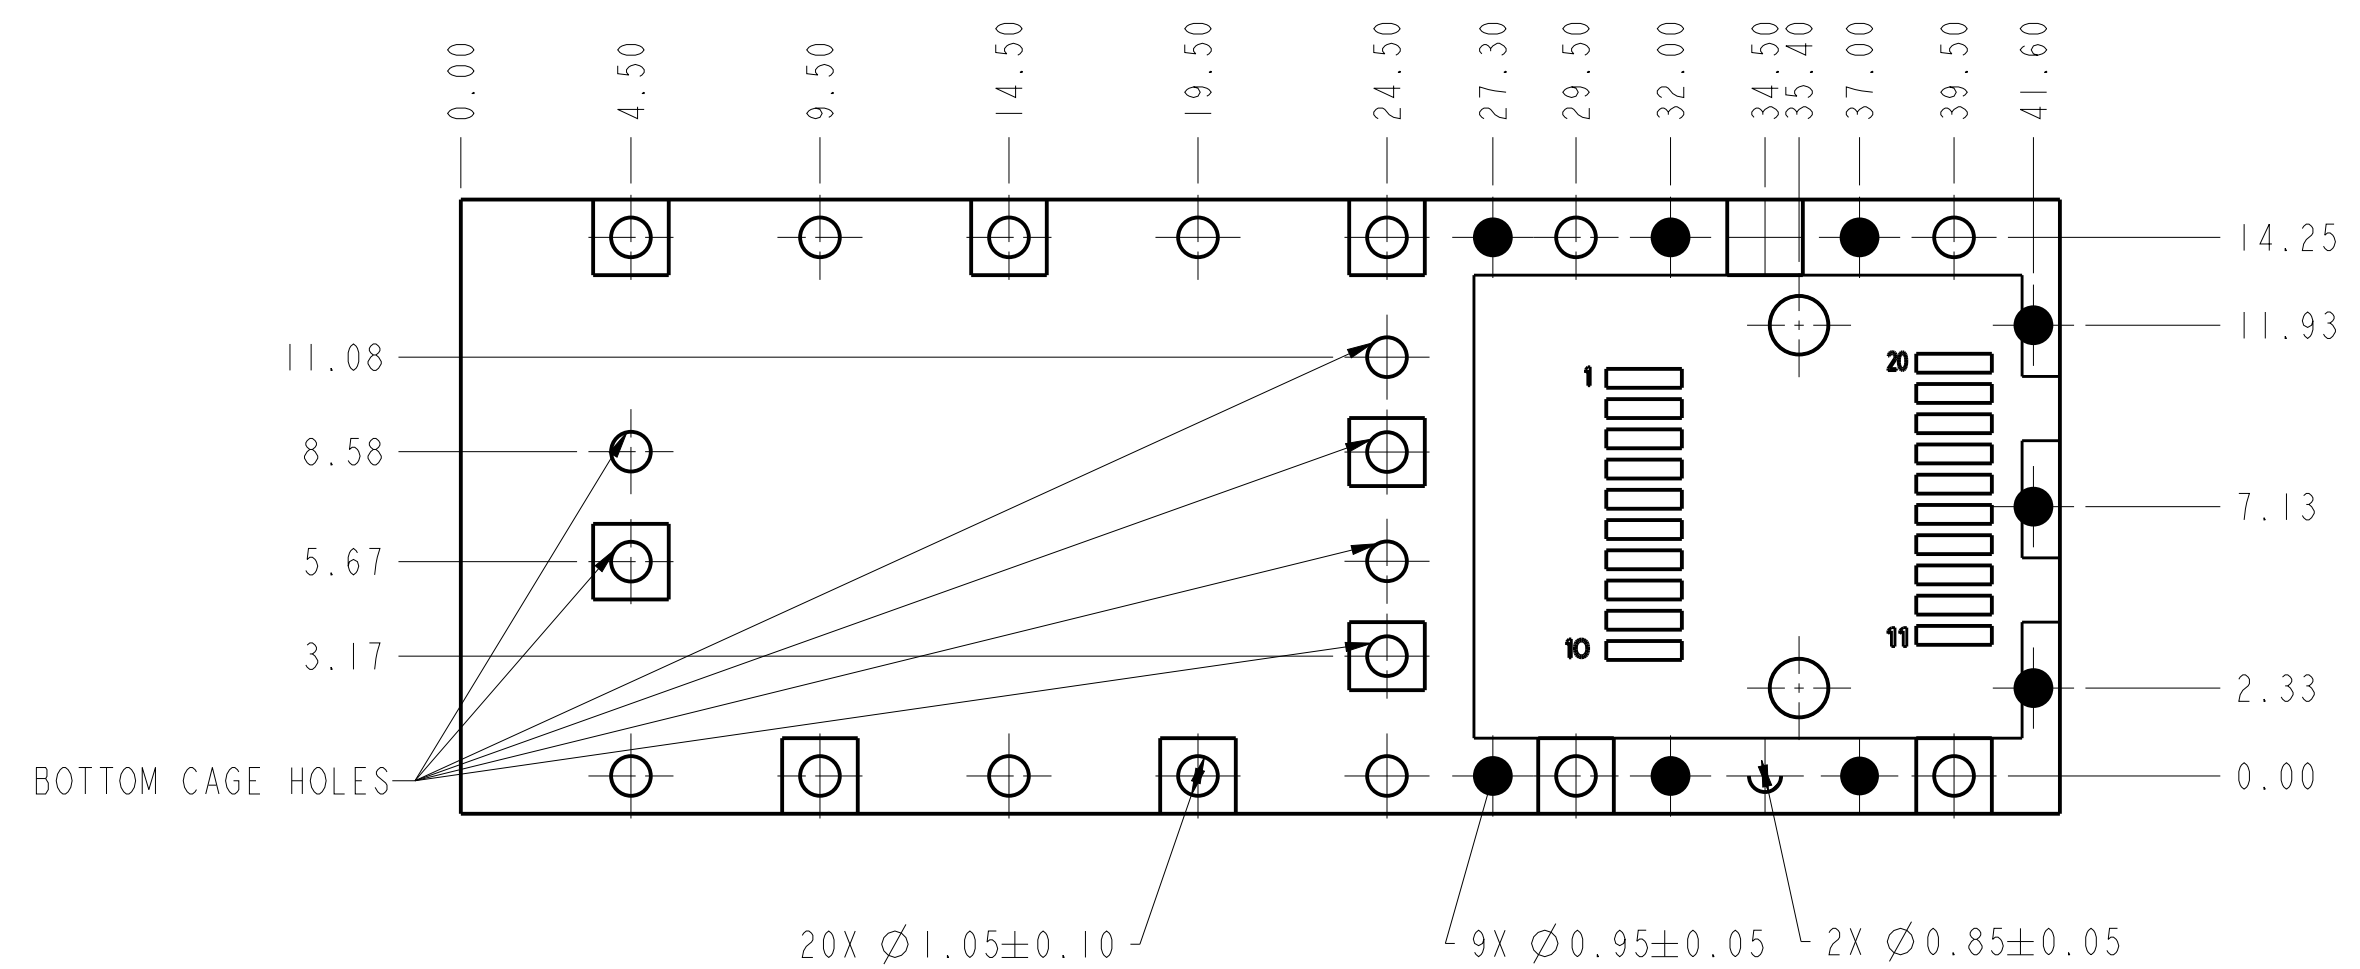

NOTE:
SEE SHEET 4 FOR
HOST CONNECTOR LAYOUT

10122382-302LF
HOST BOARD MECHANICAL LAYOUT
BELLY TO BELLY APPLICATIONS

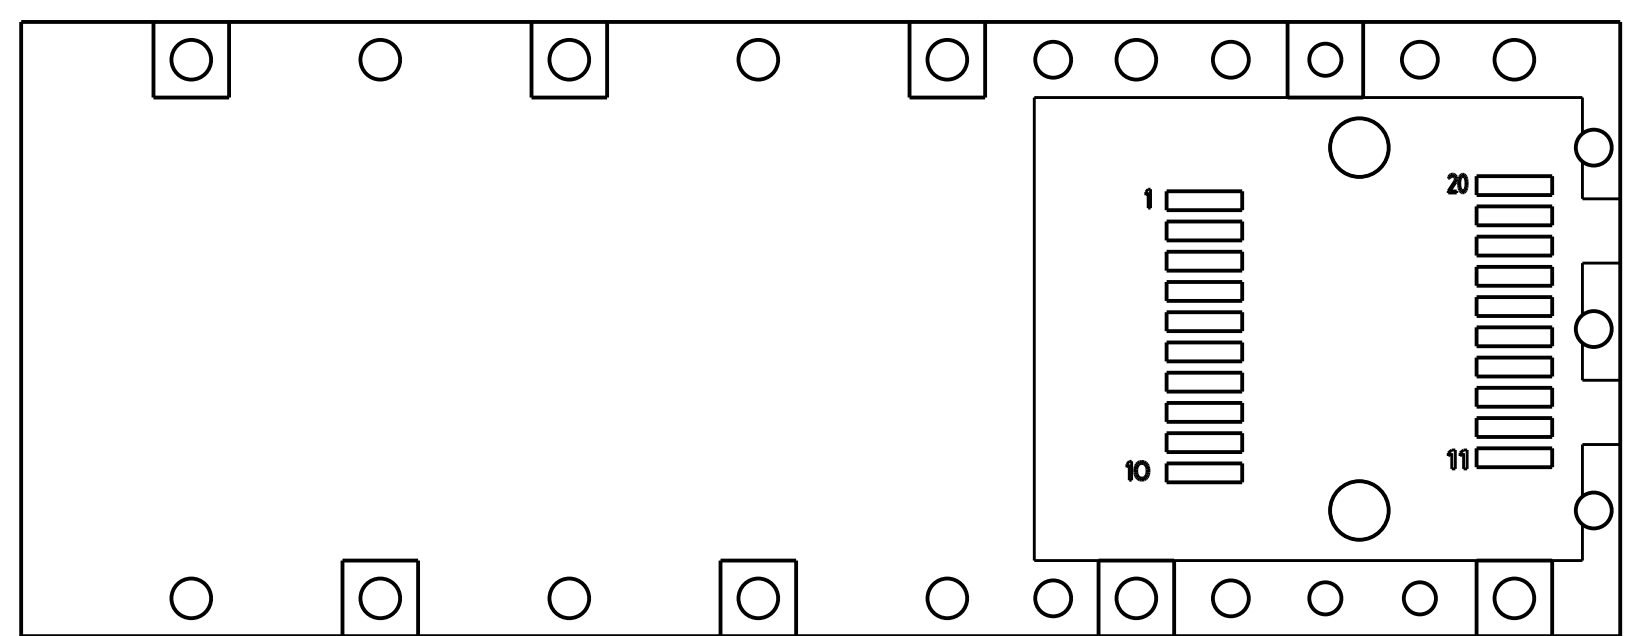



NOTE:
SEE SHEET 4 FOR
HOST CONNECTOR LAYOUT

10122382-402LF
HOST BOARD MECHANICAL LAYOUT
BELLY TO BELLY APPLICATIONS
(ONLY WITHOUT BOTTOM CAGE HOLES)



Copyright FCI.
FCI

spec ref		RELEASE			dr		ART LIN		2014-03-20		projection				size		scale							
tolerance std		TOLERANCES UNLESS OTHERWISE SPECIFIED			eng										A2		4:1							
ASME Y14.5					chr		COLLINS LU		2014-03-21						ecn no									
					appr		JEFFREY QIN		2014-03-21		product family		-		rel level		Released							
surface			linear				title		SFP+ 1X1 Cage				dwg no		10122382				rev					
																					0.X		±0.25	
																					0.XX		±0.15	
ISO 1302			angular		0°		±2°		www.fci.com		cat. no.		-		Product- Customer Drw				sheet 5 of 6					
									EMI SPRING TYPE										C					

BEZEL AND BOARD POSITION DIMENSIONS FOR SINGLE SIDE MOUNTING
(EMI SPRING FINGER)

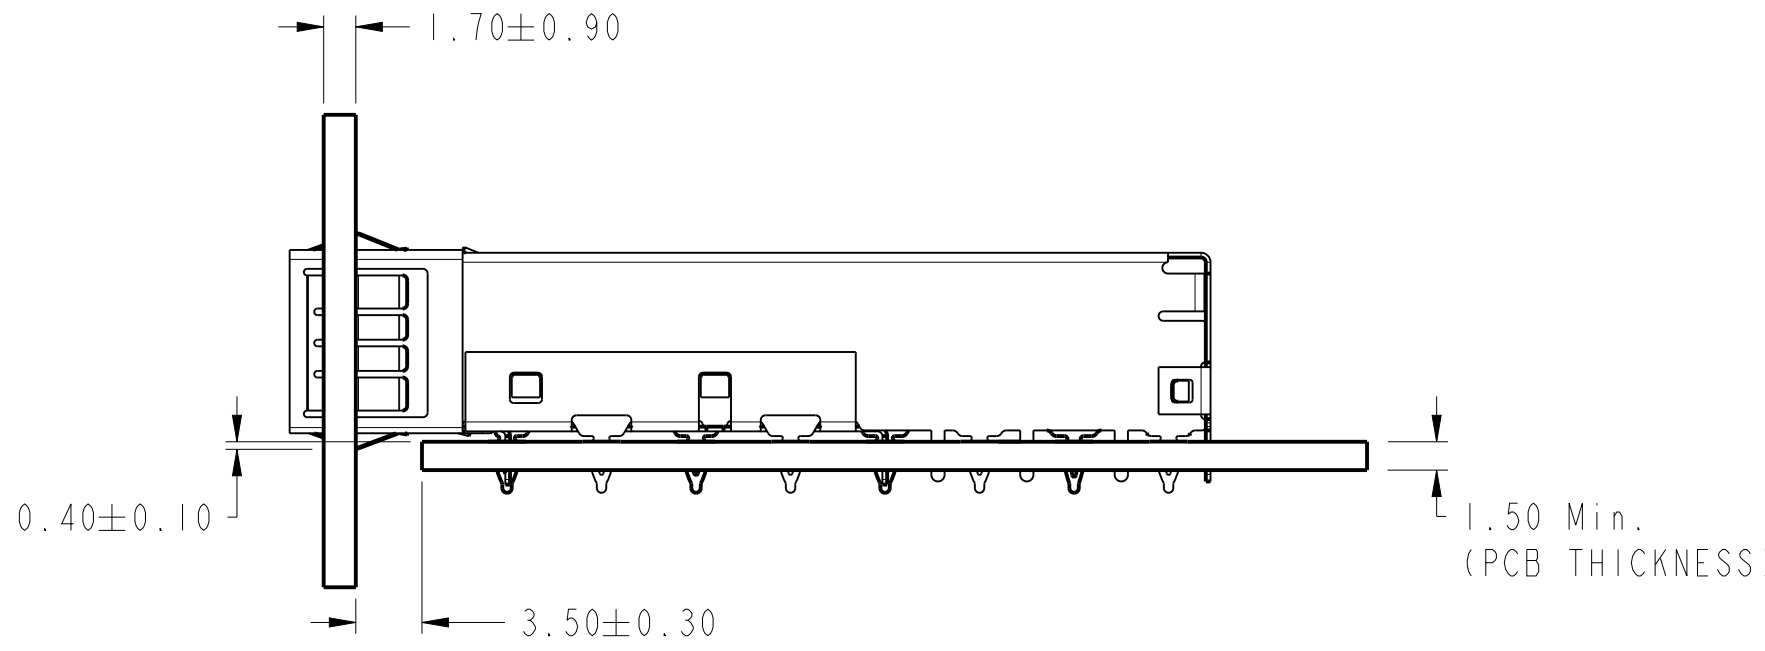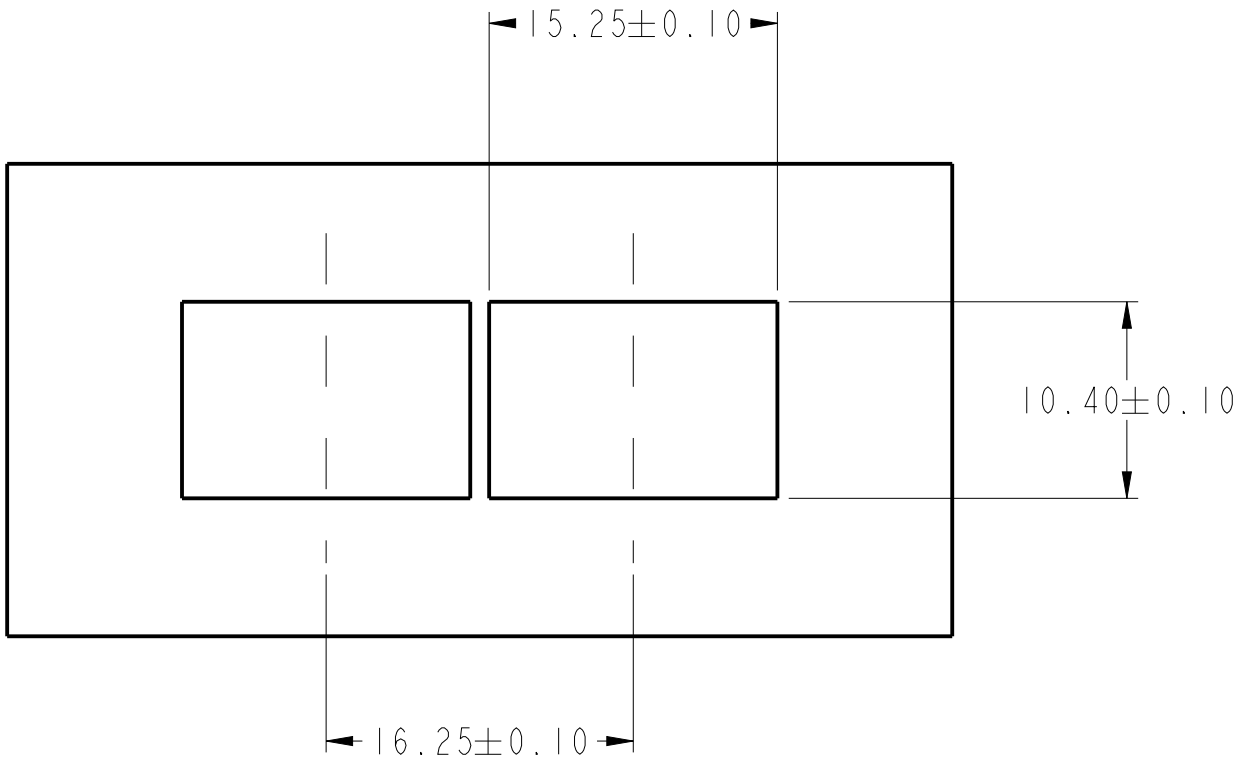

10122382-302LF/402LF
BEZEL AND BOARD POSITION DIMENSIONS FOR BELLY TO BELLY MOUNTING
(EMI SPRING FINGER)

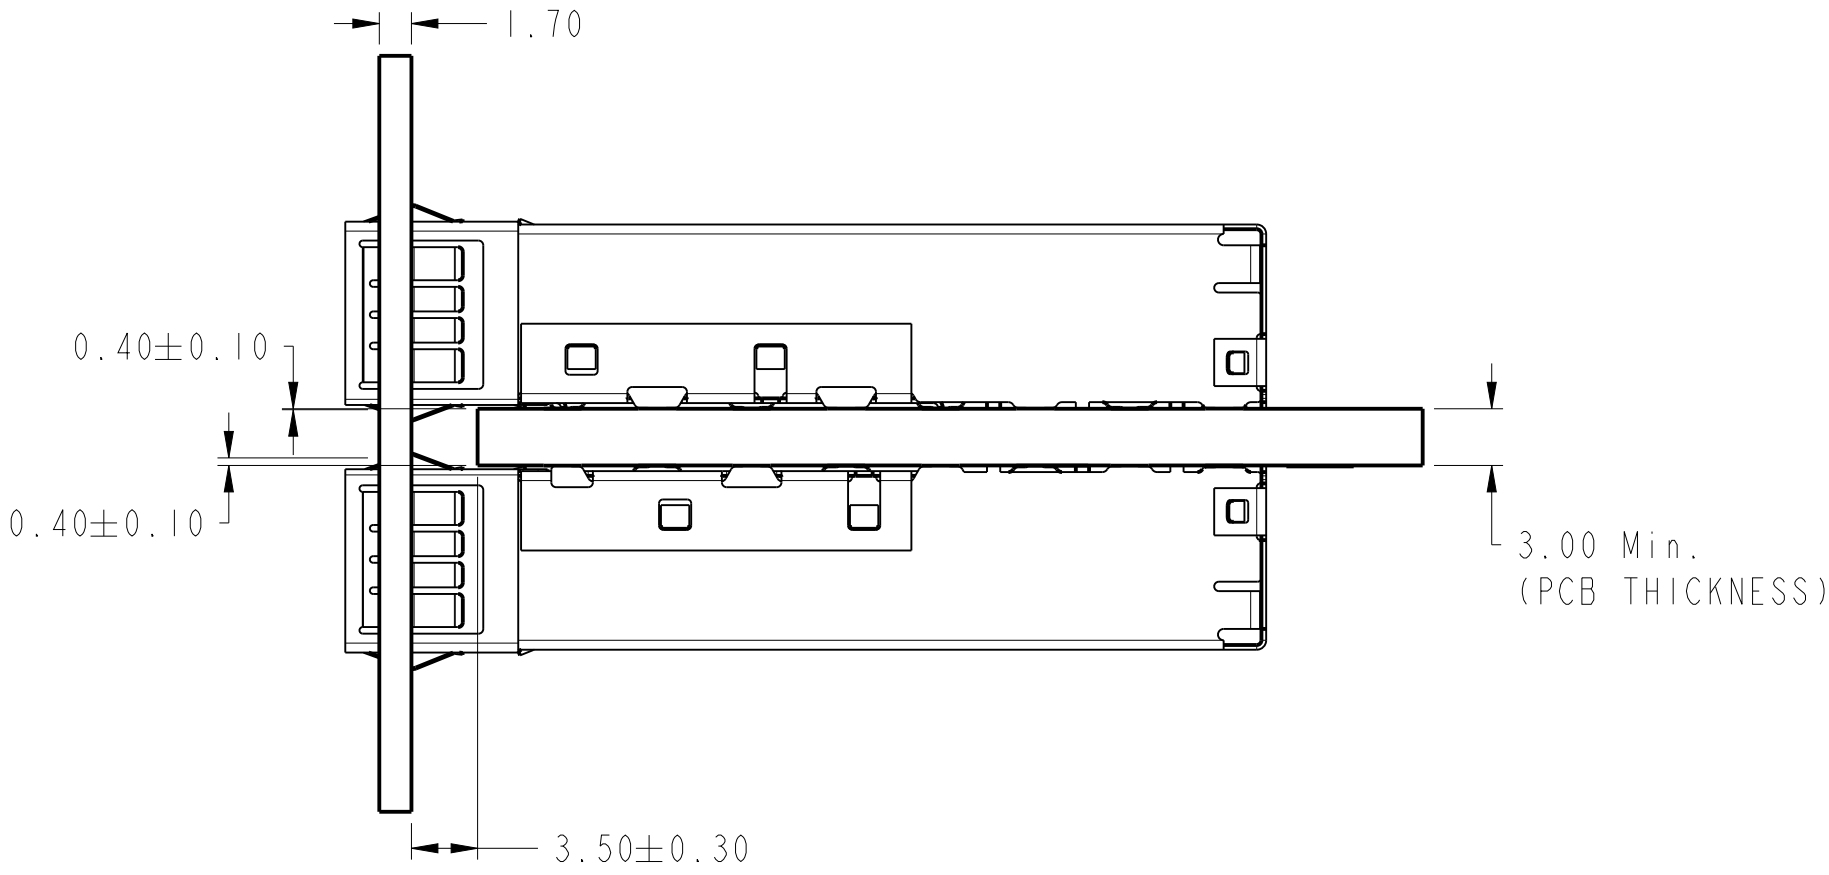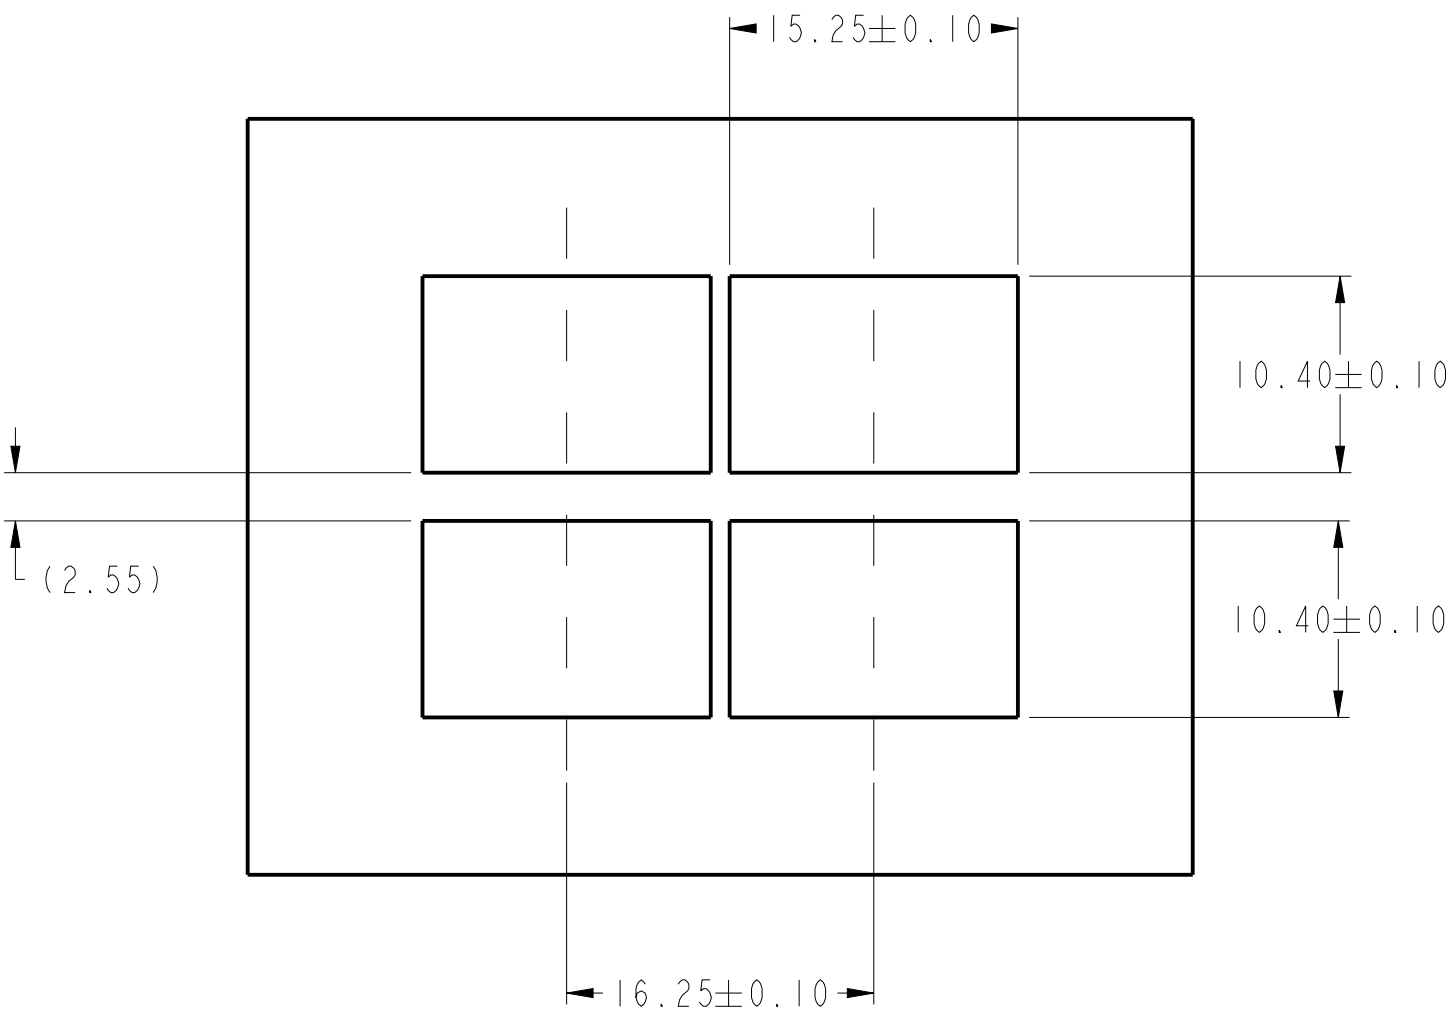

Copyright FCI.
FCI

spec ref	RELEASE			dr	ART LIN	2014-03-20	projection			size	A2	scale	5:2
tolerance std	TOLERANCES UNLESS OTHERWISE SPECIFIED			eng			ecn no			rel level			Released
ISO 406				chr	COLLINS LU	2014-03-21	product family						
ISO 1101				appr	JEFFREY QIN	2014-03-21							
surface	linear	0.X	±0.25		title	SFP+ IXI Cage		dwg no	10122382		rev	C	
		0.XX	±0.15										
		0.XXX	±-										
	ISO 1302	angular	0°										±2°